


KEY PLAN:
SCALE: N.T.S.

- NOTES:**
- DRAWING ONLY DISPLAYS SURFACE WATER DRAINAGE NETWORK SW/2 FOR CLARITY AS THIS NETWORK SHALL BE CONNECTED INTO FROM MODIFIED HFO BUND AND PROPOSED AUXILIARY BOILER HOUSE

LEGEND

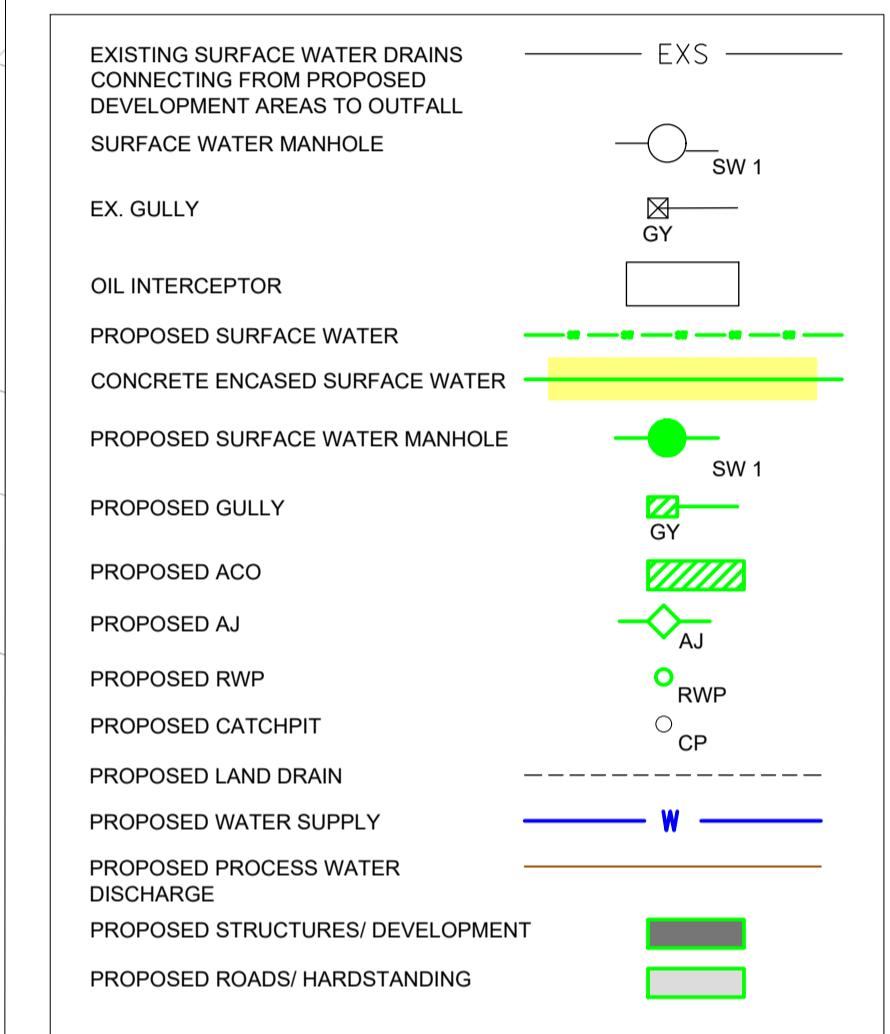

SCALE 1:500
 0 10 20 30 40 50
 O.S.I. 1:50000 VECTORS TILE NUMBERS 4789 & 4790 ARE SHOWN ON THIS DRAWING
 TAILTE ÉIREANN LICENCE NO. EN 0023719-24
 © TAILTE ÉIREANN/GOVERNMENT OF IRELAND

REV	DATE	REVISION DESCRIPTION	DRN	PROD	VER	APP
000	12.2023	ISSUED FOR PLANNING	AB	HG	ED	JH

COPYRIGHT © ESB
 ALL RIGHTS RESERVED. NO PART OF THIS WORK MAY BE MODIFIED, REPRODUCED OR COPIED IN ANY FORM OR BY ANY MEANS - GRAPHIC, ELECTRONIC OR MECHANICAL, INCLUDING PHOTOCOPIING, RECORDING, TAPING OR USED FOR ANY PURPOSE OTHER THAN ITS DESIGNATED PURPOSE, WITHOUT THE WRITTEN PERMISSION OF ESB.

PURPOSE OF ISSUE - PRELIMINARY UNLESS INDICATED
 CLIENT APPROVAL PLANNING TENDER CONSTRUCTION AS-BUILT

CLIENT: ESB GENERATION & TRADING

PROJECT: MONEYPPOINT SECURITY OF SUPPLY PROJECT

CONTRACT:

DRAWING TITLE: PROPOSED DRAINAGE PLAN SHEET 3 OF 3

PRODUCTION UNIT: Civil, Environmental & Renewable Engineering

Engineering and Major Projects,
 One Dublin Airport Central, Dublin Airport,
 Cloughran, Co. Dublin, K67 XF72, Ireland.
 Tel: +353 (0)1 703 8000 Web: www.esb.ie
 Engineering and Major Projects is a division of ESB.

DRAWN	PRODUCED	VERIFIED	APPROVED	APPROVAL DATE
A. Buttur	H. Griffin	E. Dunphy	J. Havery	Dec 2023
CLIENT REF	NO. OF SHTS	SIZE	SCALE	
	3	A1	1:500	

DRAWING NUMBER: QP-000017-65-D451-009-003-000
 SHEET: 3 REV: 0

